

Appendix B

DO NOT SOLICIT CONTRACTS TO VERIFY ALL PROPOSALS FOR GENERAL BUILDING, WITH SPECIALS, MECHANICAL, ELECTRICAL, AND OUTSOURCING ARE TO BE APPORTIONED TO THE ARCHITECT

FOR ALL DETAILS OF FOUNDATIONS, COLUMNS, BEAMS, JOISTS, ROOF STRUCTURAL ENGINEER'S DRAWINGS

FOR LOCATION AND DETAILS OF MECHANICAL AND ELECTRICAL EQUIPMENT, SEE ELECTRICAL AND MECHANICAL DRAWINGS

KEY TO DETAILS

on 12/10/10. on 12/10/10
on 12/10/10

REVISION	DATE	INITIALS	REVISION DETAILS
----------	------	----------	------------------


CHATELAIN
SOUFRIERE HOSPITAL
EXTENSION.

PLAYING TITLE SITE PH

ARCHITECTURAL SECTION
CENTRAL PLANNING UNIT
POST OFFICE BOX 709
CASTRIES, SAINT LUCIA

SHEET No	SCALE	DATE	DRAWN	REVISIONS		APPROVED
				CHECKED		

DRAWING No.
A-79-51

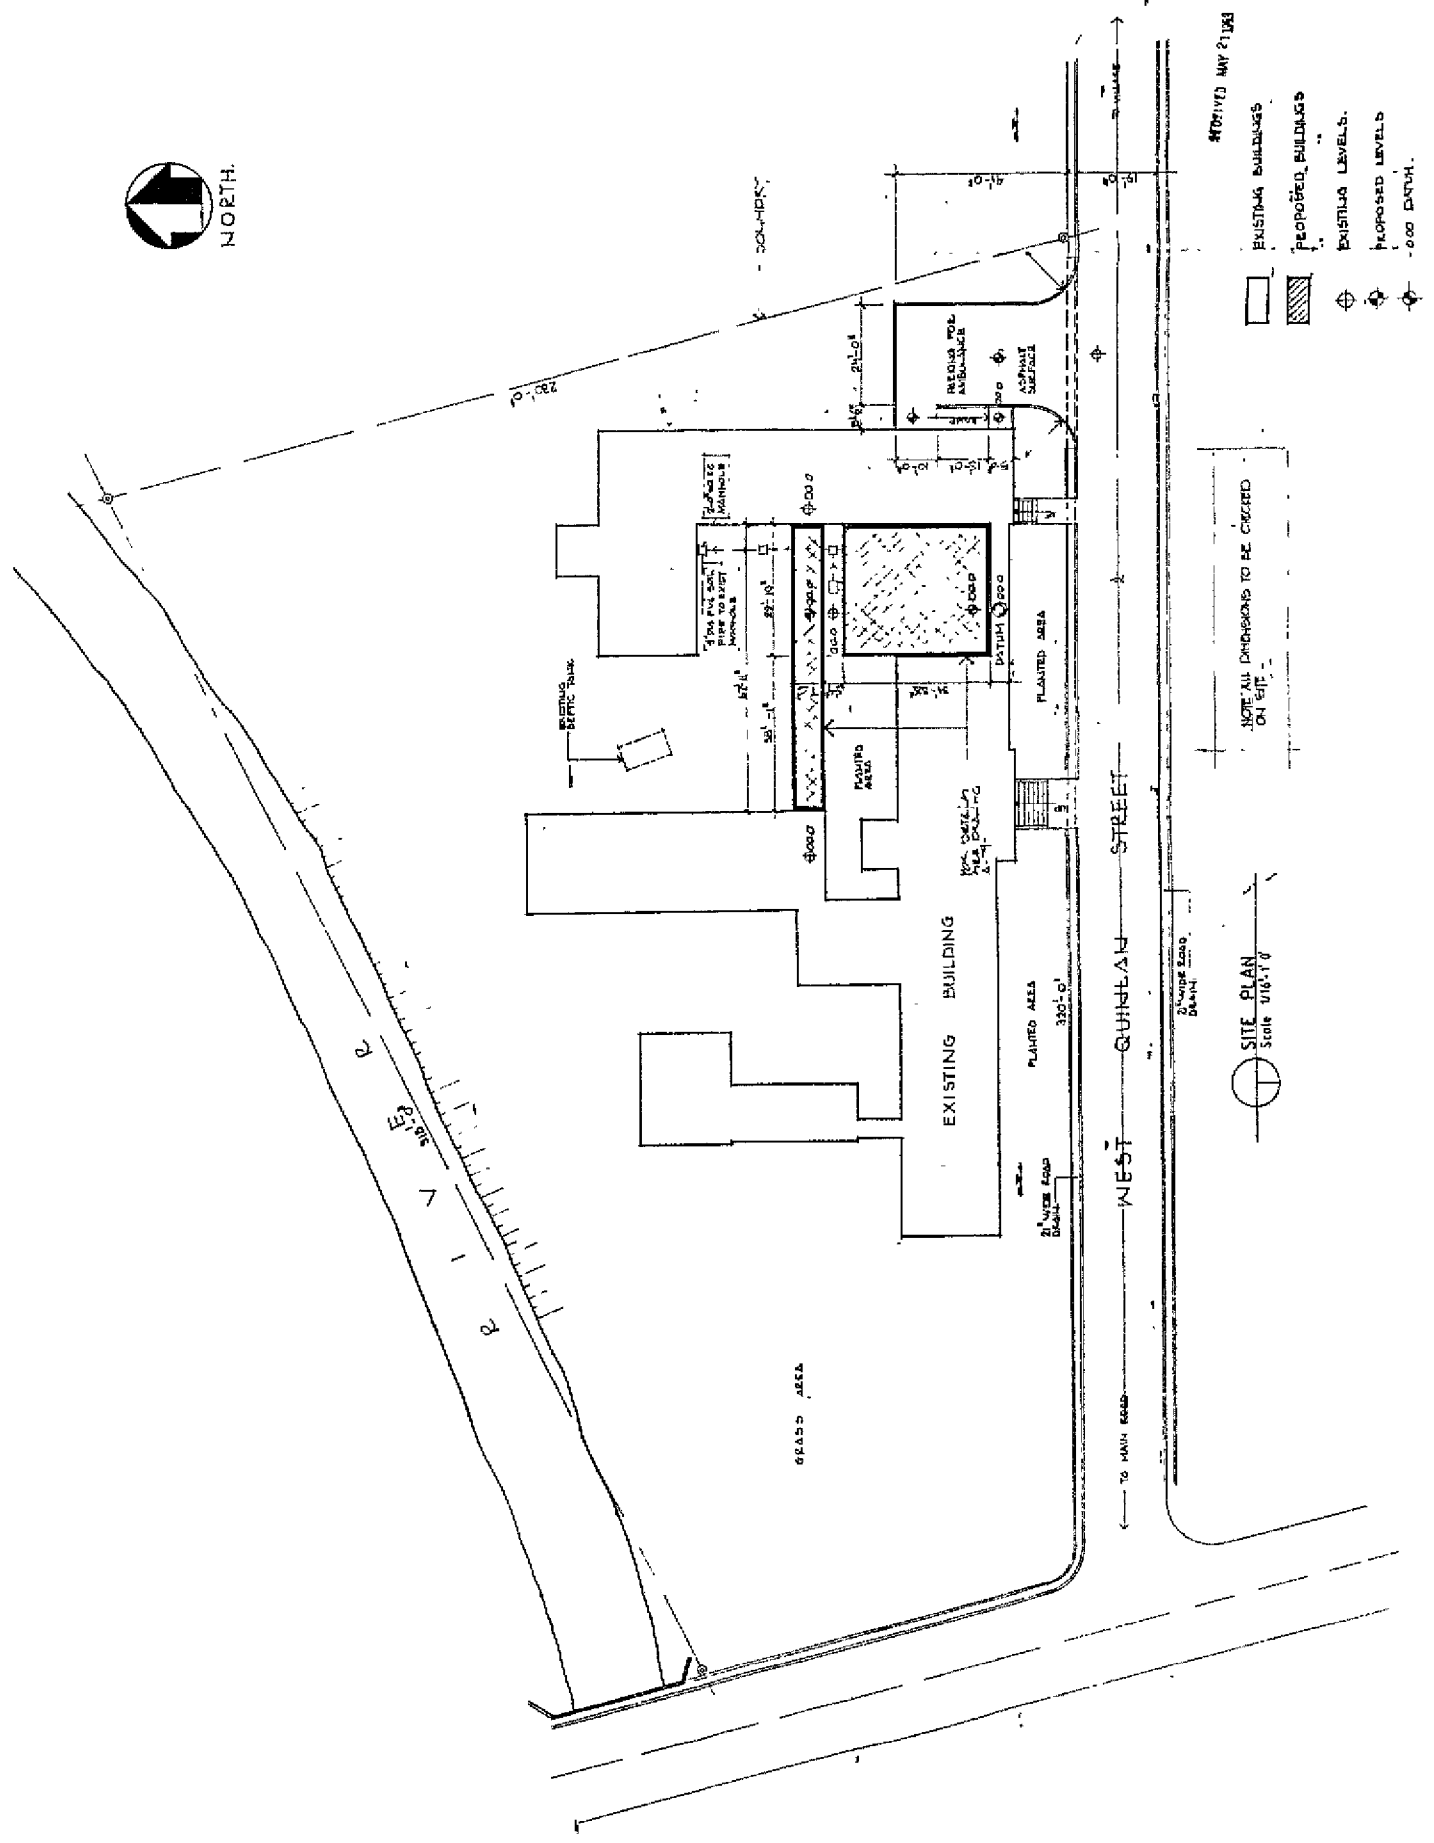

650112 AMY 07241500Z

ALLS THE
CHIEF OF POLICE

SITE PLAN
Scale 1/16" = 1' 0"

EXISTING BUILDINGS	PROPOSED BUILDINGS	EXISTING LEVELS	PROPOSED LEVELS	DOO DATA

DO NOT SCALE
CONTRACTOR TO VERIFY ALL
DIMENSIONS AND LOCATIONS
BEFORE PROCEEDING WITH WORKS.
ALL WORKS AND DIMENSIONS
ARE TO BE REPORTED TO THE
ARCHITECT
FOR ALL DETAILS OF FOUNDATION,
CONCRETE, BRICK, BLOCK, ETC.
SEE ARCHITECT'S DRAWINGS
FOR LOCATION AND DETAILS OF
MECHANICAL AND ELECTRICAL
WORK. SEE ELECTRICAL AND
MECHANICAL ENGINEER'S DRAWINGS
CLERY TO DETAILS




REVISION	DATE	INITIALS	REVISION DETAILS

PROJECT
SOUFRIERE HOSPITAL
EXTENSION

DRAWING TITLE
FLOOR PLAN

ARCHITECTURAL SECTION
CENTRAL PLANNING UNIT
POST OFFICE BOX 709
CASTRIES, SAINT LUCIA

SHEET NO.	DESIGNED BY	DATE	APPROVED
	A-79-52	DEC 92	
SCALE	AS SHOWN	DATE	APPROVED

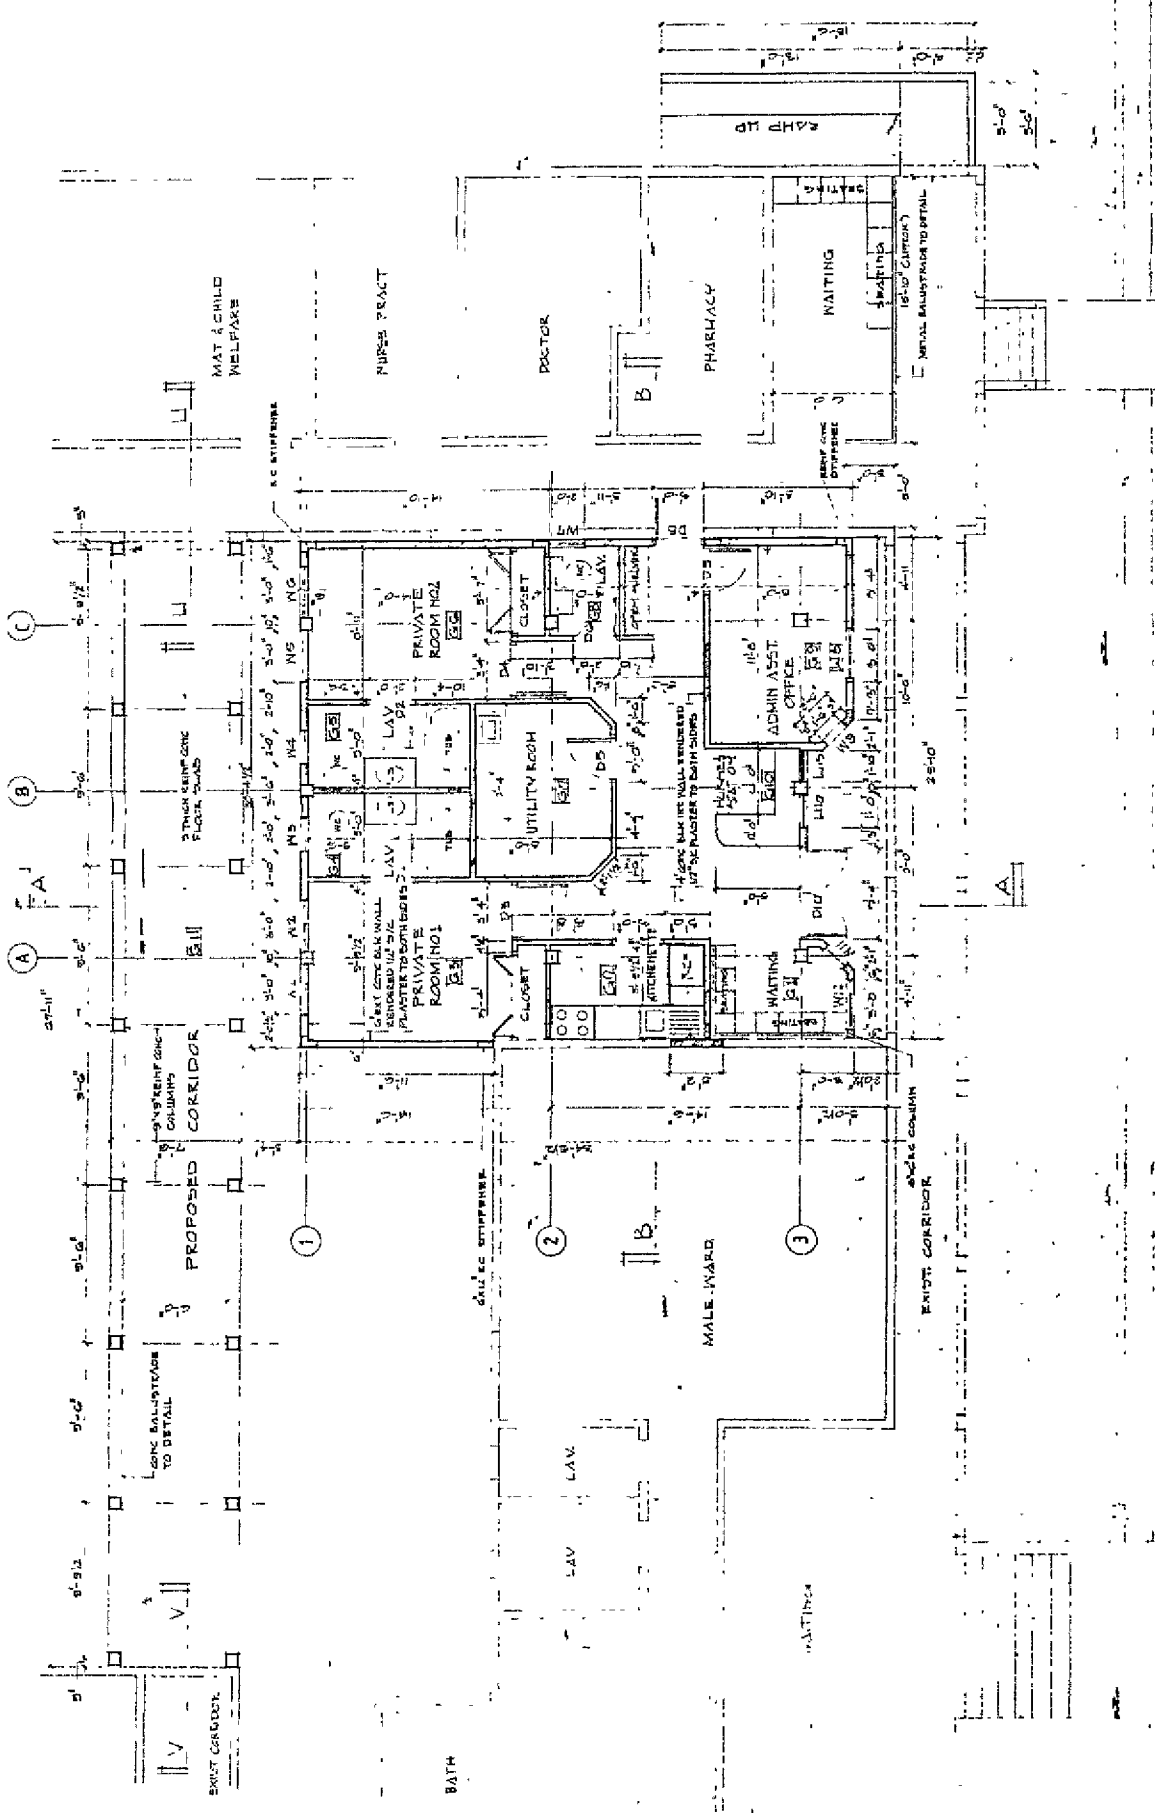

LEGEND

SYMBOLS	DESCRIPTION
---	EXISTING WORK
---	TO BE RETAINED
---	EXISTING WORK TO BE DEMOLISHED
---	PROPOSED WORK

LONG BLOCK BUILDING HOSPITAL
CENTRAL PLANNING UNIT
POST OFFICE BOX 709
CASTRIES, SAINT LUCIA

WEST QUINLAN STREET

FLOOR PLAN
scale: 1/4" = 1'-0"

DO NOT SCALE
CONTRACTOR TO VERIFY ALL
DIMENSIONS ON SITE BEFORE
PROCEEDING WITH WORKS...
ALL ERRORS AND OMISSIONS
ARE TO BE REPORTED TO THE
ARCHITECT.

FOR ALL DETAILS OF FOUNDATION,
COLLIES, BEAMS, SLAB, ETC. SEE
STRUCTURAL ENGINEER'S DRAWINGS.

FOR ALL DETAILS AND LOCATION
OF MECHANICAL AND ELECTRICAL
EQUIPMENT, SEE MECH AND ELEC
ENGINEER'S DRAWINGS.

KEY TO DETAILS.

11/11/11
 11/11/11
 11/11/11

REVISION: SUFFIX	DATE	INITIALS	REVISION DETAILS
---------------------	------	----------	------------------


JOB TITLE
SOUFRIERE HOSPITAL
EXTENSION

DRAWING TITLE
SECTIONS/
SECTION DETAILS

ARCHITECTURAL SECTION
CENTRAL PLANNING UNIT
POST OFFICE BOX 709
CASTRIES, SAINT LUCIA

DRAWING NO. A-79-53	REVISIONS	CHECKED	APPROVED
SHEET NO.	SCALE AS SHOWN	DRAWN	DATE

REF ID: A67210

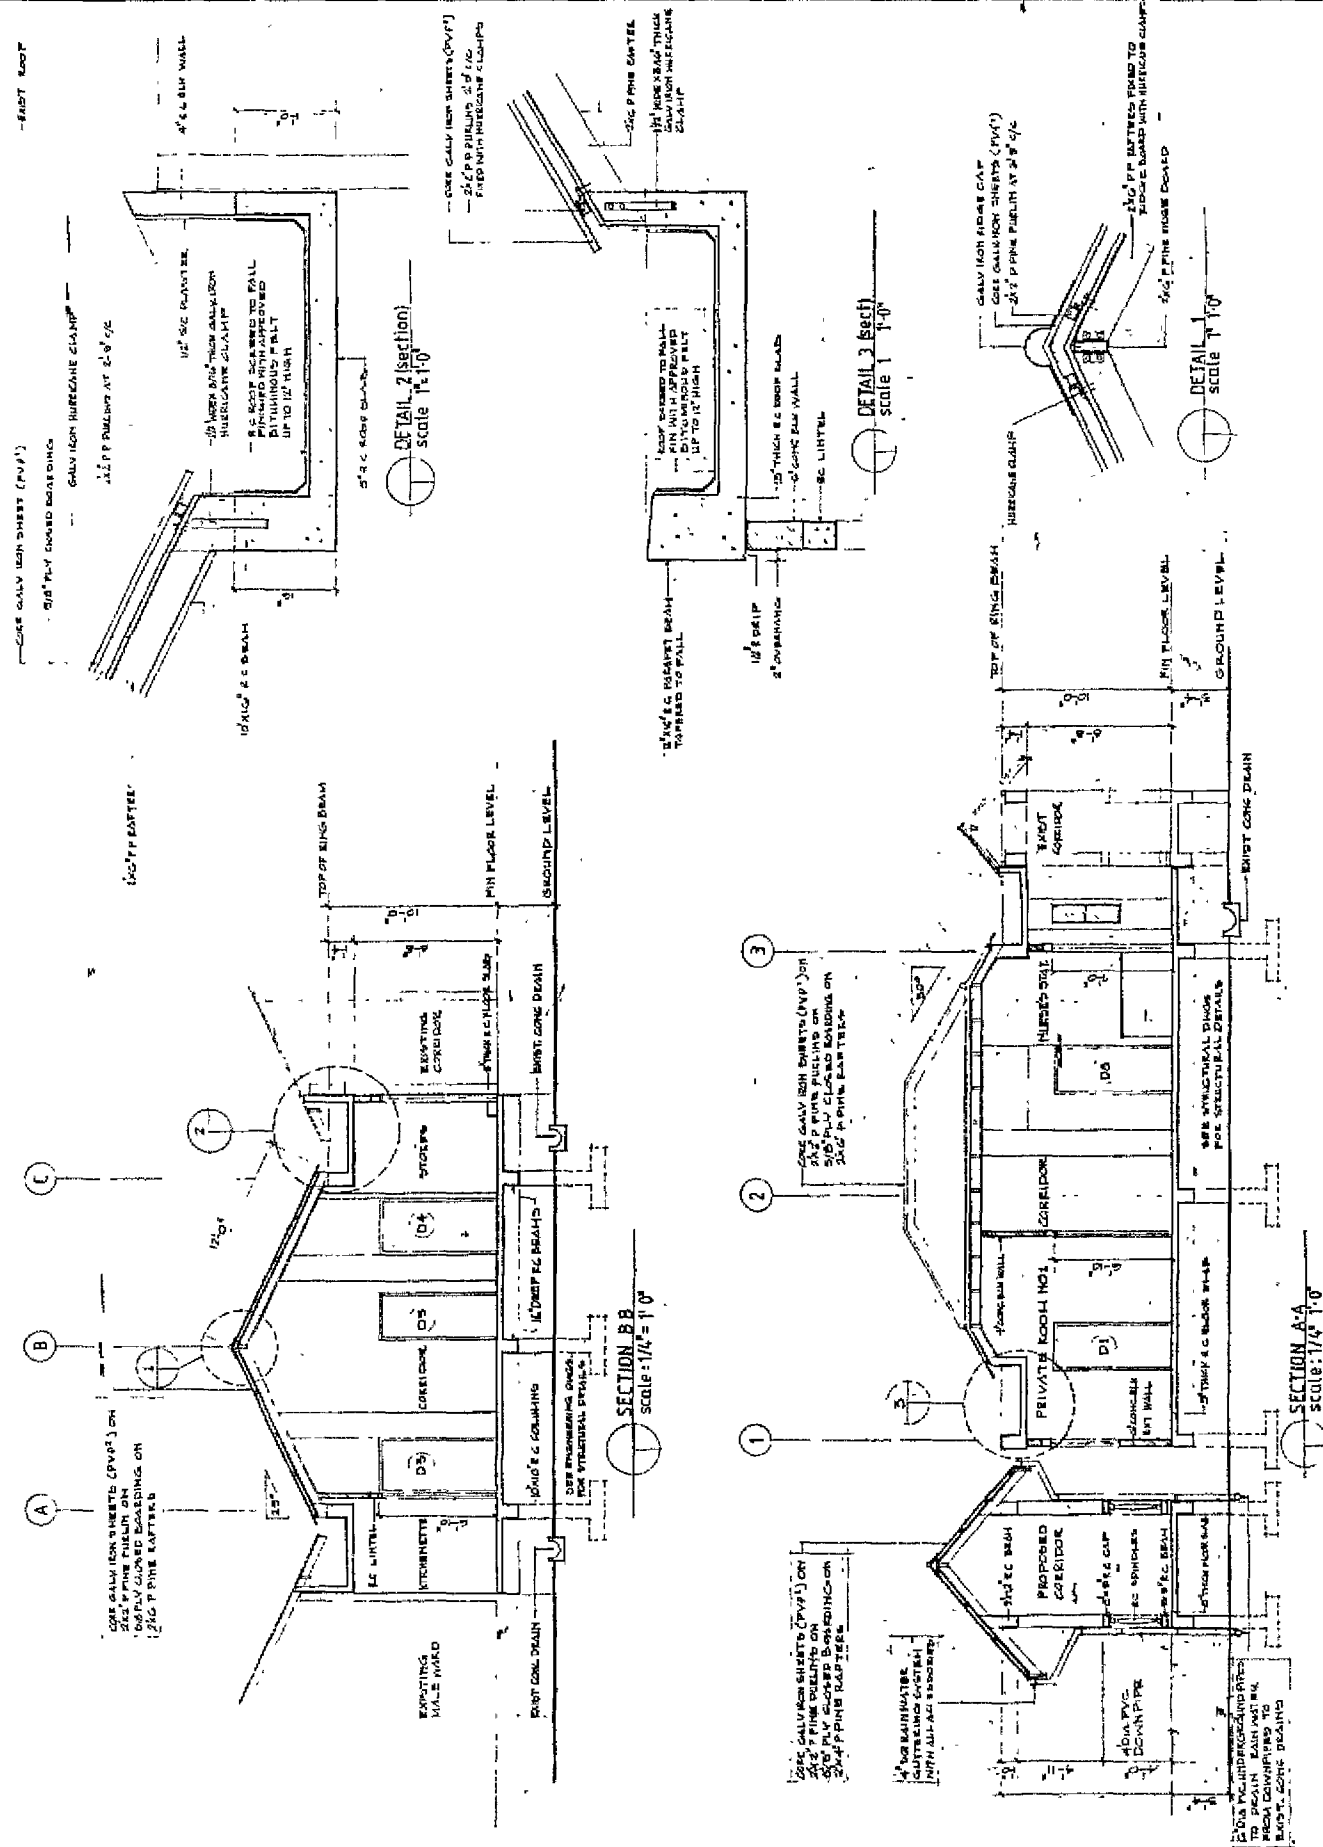

DO NOT SCALE

DO NOT SCALE
CONTRACTOR TO VERIFY ALL
DIMENSIONS ON SITE BEFORE
PROCEEDING WITH WORKS.
ALL ERRORS AND OMISSIONS
ARE TO BE REPORTED TO THE
ARCHITECT

FOR ALL DETAILS OF FOUNDATION,
COLUMNS, BEAMS, WALLS, ETC. SEE
STRUCTURAL ENGINEER'S DRAWING
FOR LOCATION AND DEPTH OF
HIGH AND LOW TIGHTENING SEE
ECC AND HIGH ENGINEER'S
DRAWING'S

STUDY OF JIN

	PENSION DETAILS	INITIALS	DATE	REMARKS IF ANY.

JOB TITLE
SOUFRIERE HOSPITAL
EXTENSION


THE STATE OF TEXAS,

ELEVATIONS

ARCHITECTURAL SECTION
CENTRAL PLANNING UNIT
POST OFFICE BOX 709
CAASTRIES, SAINT LUCIA


SHEET NO.	SCALE	AS STATED	DATE	BY	CHECKED	APPROVED
			MAY 1979	H. A.		
DRAWING NO.		A-79-54		SECTION		

RECEIVED MAY 27 1953

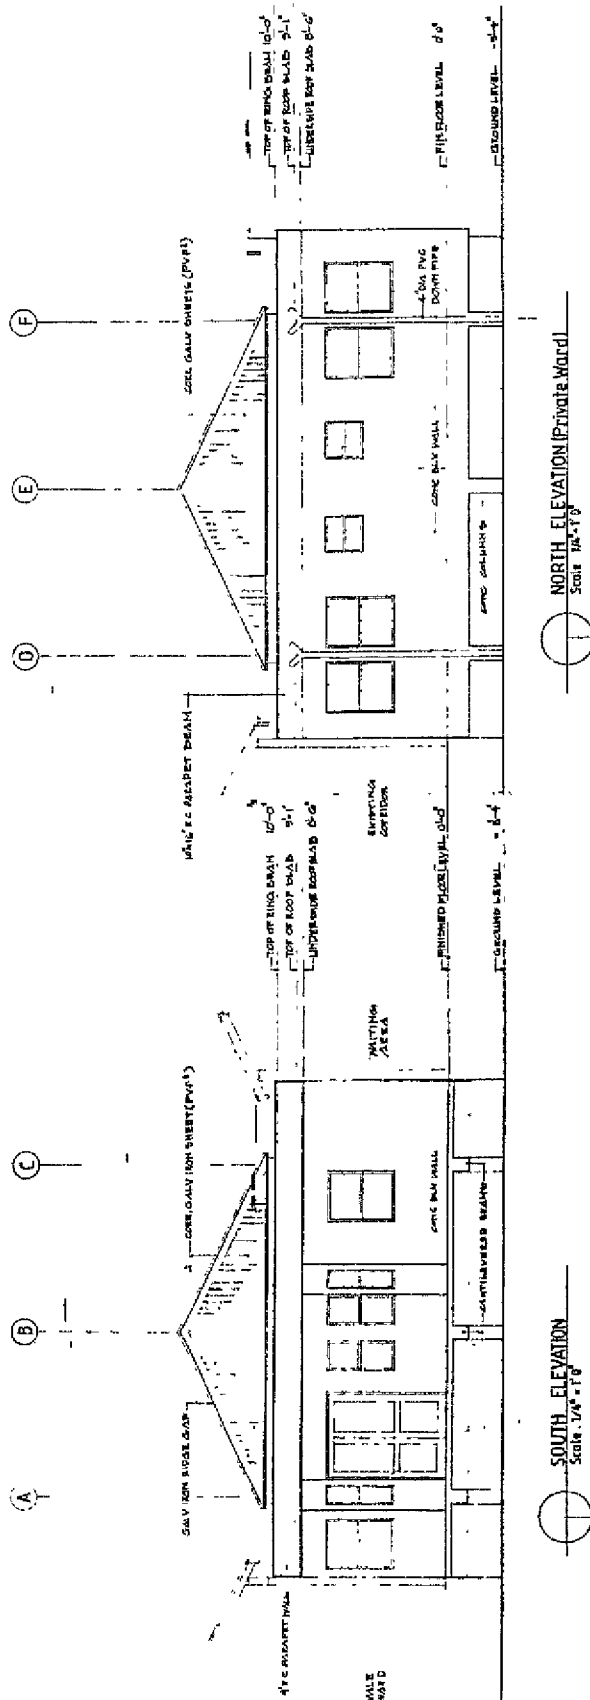

SOUTH ELEVATION
Scale: 1/4" = 1'-0"

NORTH ELEVATION (Private Ward)

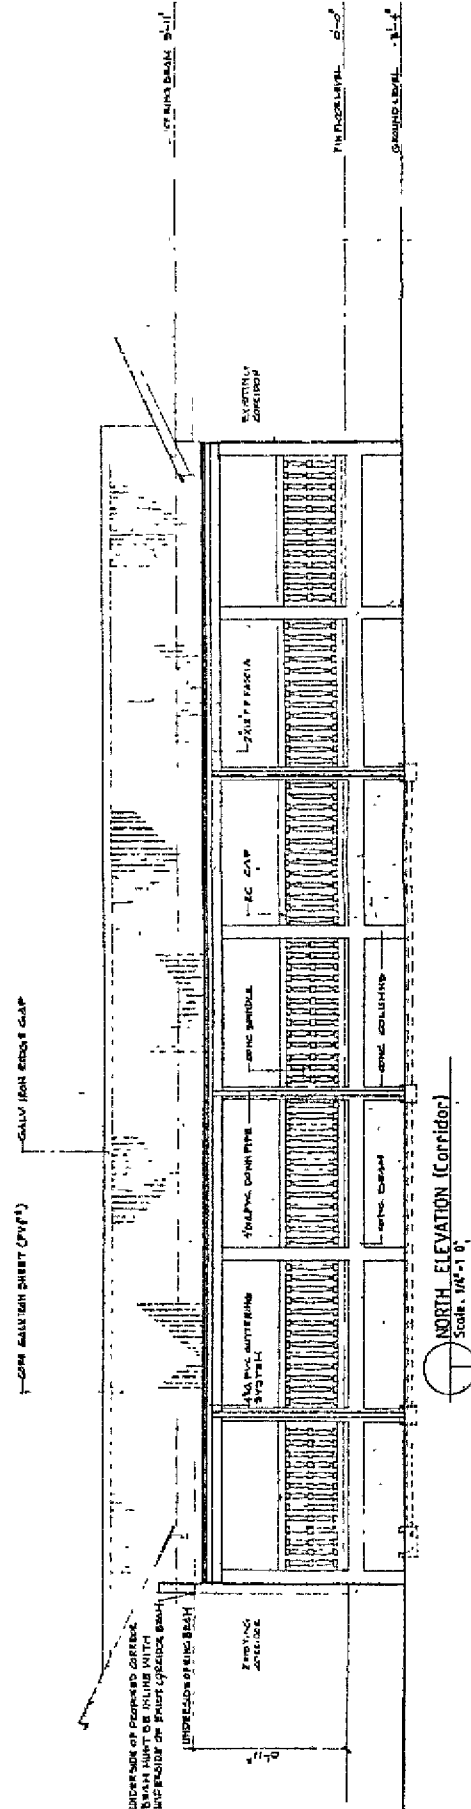

NORTH ELEVATION (Corridor)
Scale: 1/4" = 1' 0"

NOTES AND REVISIONS

1:50 NOT SCALE
 CONTRACTOR TO VERIFY ALL DIMENSIONS
 ON SITE BEFORE PROCEEDING WITH WORKS
 THE REVISIONS AND CHANGES ARE
 TO BE CARRIED TO THE ARCHITECT
 FOR ALL DETAILS OF FOUNDATION
 WORKS TO BE CARRIED TO THE
 STRUCTURAL ENGINEER'S DRAWING.
 FOR LOCATION AND DETAILS OF HIGH
 AND ELECTRICAL EQUIPMENT SEE P.E.C.
 AND THE ELECTRICAL DRAWINGS
 SHEET TO DETAILS.



REVISION	DATE	INITIALS	REVISION DETAILS


PROJECT TITLE
 SOUFFRIERE HOSPITAL
 EXTENSION

DRAWING TITLE
 TOILET AND
 KITCHEN DETAILS


ARCHITECTURAL SECTION
 CENTRAL PLANNING UNIT
 POST OFFICE BOX 708
 CASTRIES, SAINT LUCIA

SHEET NO.	DATE	DESIGNED	CHECKED	APPROVED
1	1981	A-79-56		
DRAWN	DATE			
1	1981			


USE RUN OF STEPS CORSE TO BE
 APPROVED AND TO BE SELECTED
 BY ARCHITECT

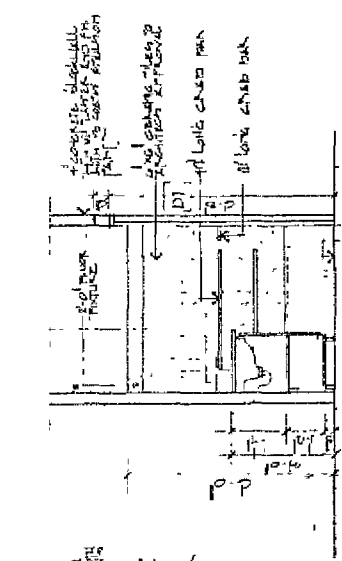


Section B-B
 scale 1/8" = 1'-0"

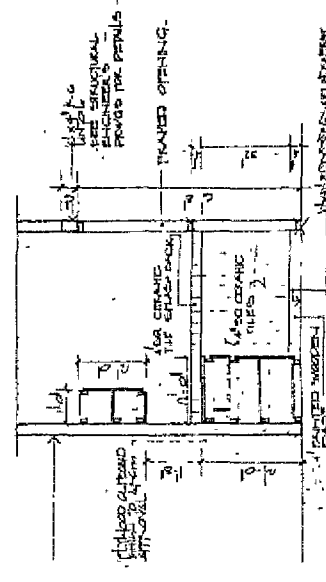


Section
 scale 1/8" = 1'-0"

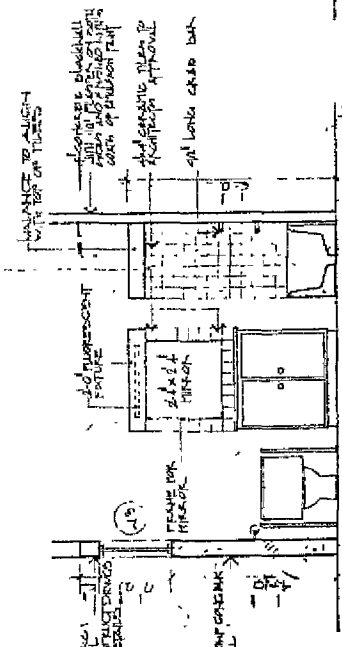


Section
 scale 1/8" = 1'-0"

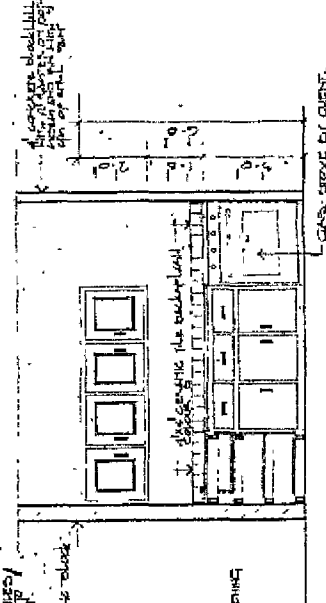

Section
 scale 1/8" = 1'-0"




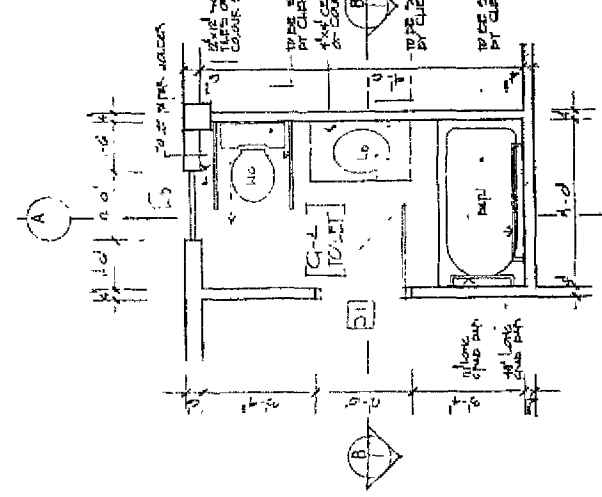


PLAN OF TOILET G-4
 scale 1/8" = 1'-0"

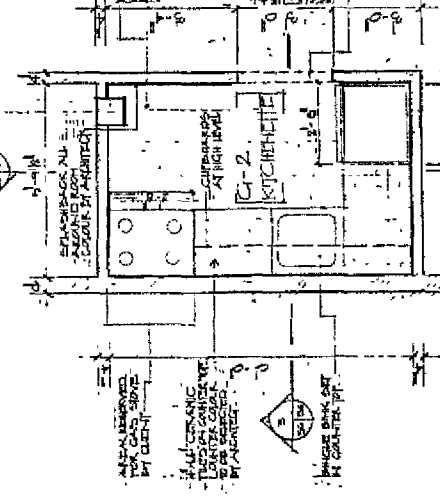

Kitchen (Plan)
 scale 1/8" = 1'-0"

1:50 NOT SCALE

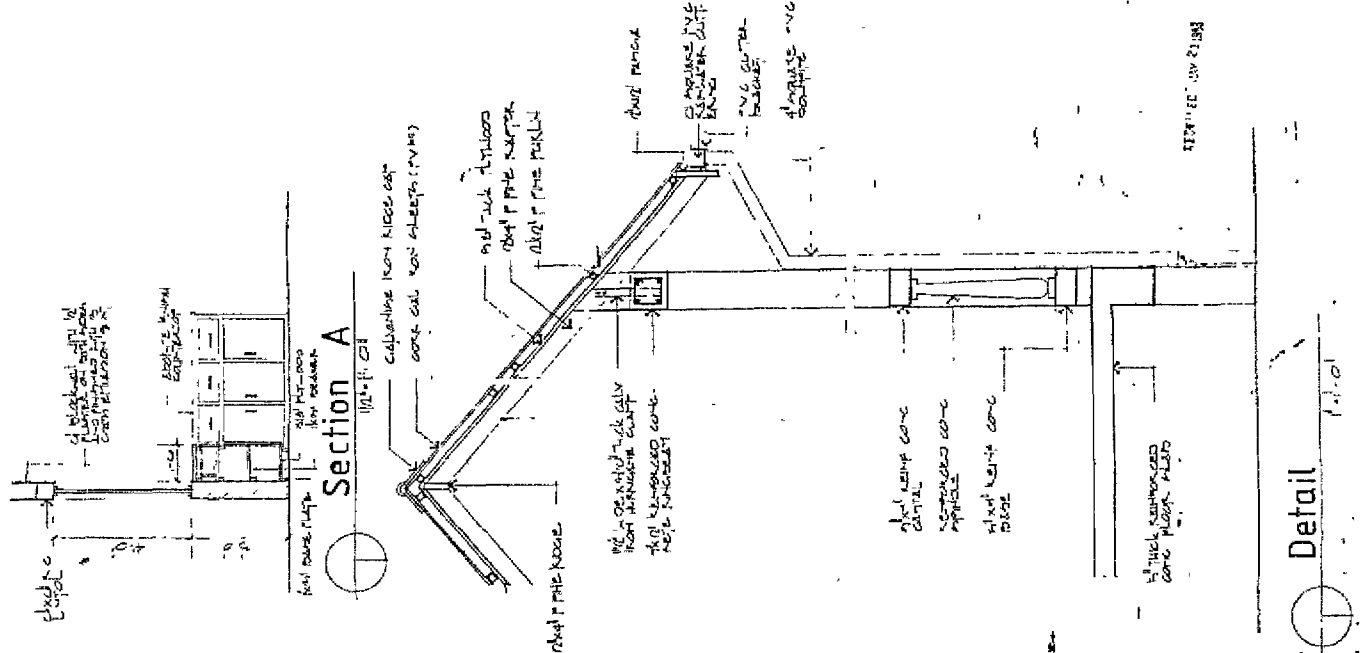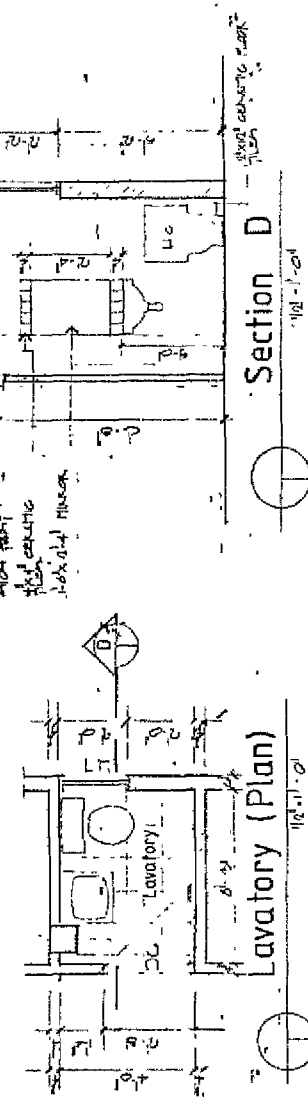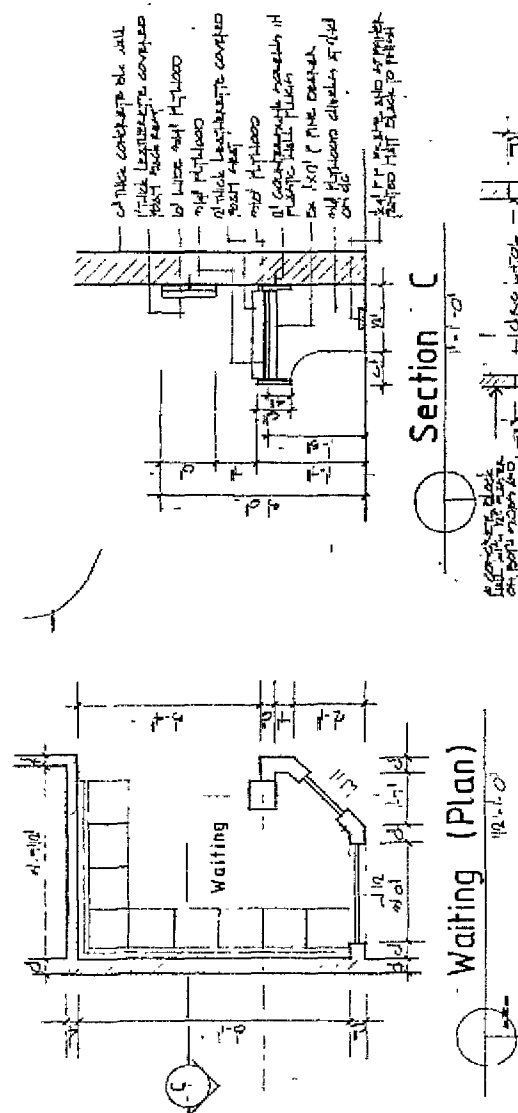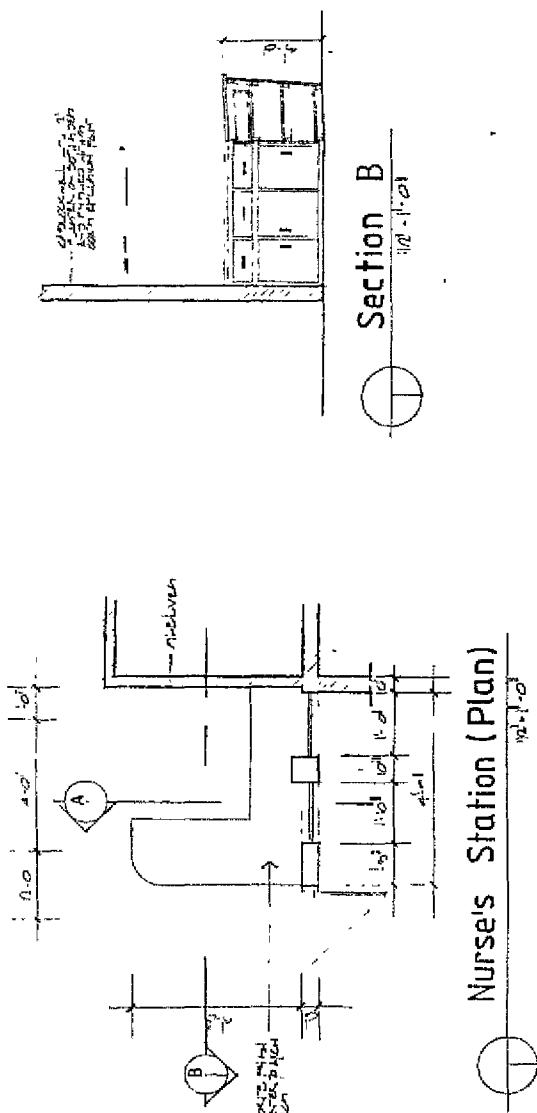

NOTES AND REVISIONS

DO NOT SCALE. DIMENSIONS ON SITE BRIDGE. PROCEED WITH WORK. ALL ERRORS AND OMISSIONS ARE TO BE REPORTED TO THE ARCHITECT. ALL DETAILS OF TOLERANCE, COORDINATE, SHALL BE THE ARCHITECT'S RESPONSIBILITY. MECHANICAL ENGINEER'S DRAWINGS. SET TO DETAILS.

SECTION DATA INITIALS

REVISIONS

PROJECT TITLE

SOUFRIERE HOSPITAL EXTENSION

DATE

12/92

SCALE

AS SHOWN

APPROVED

DATE

DEC 92

DRAWING TITLE

FLOOR PLAN

PROJECT NO.


A-79-50

ARCHITECTURAL SECTION

CENTRAL PLANNING UNIT

POST OFFICE BOX 709

CASTRIES, SAINT LUCIA

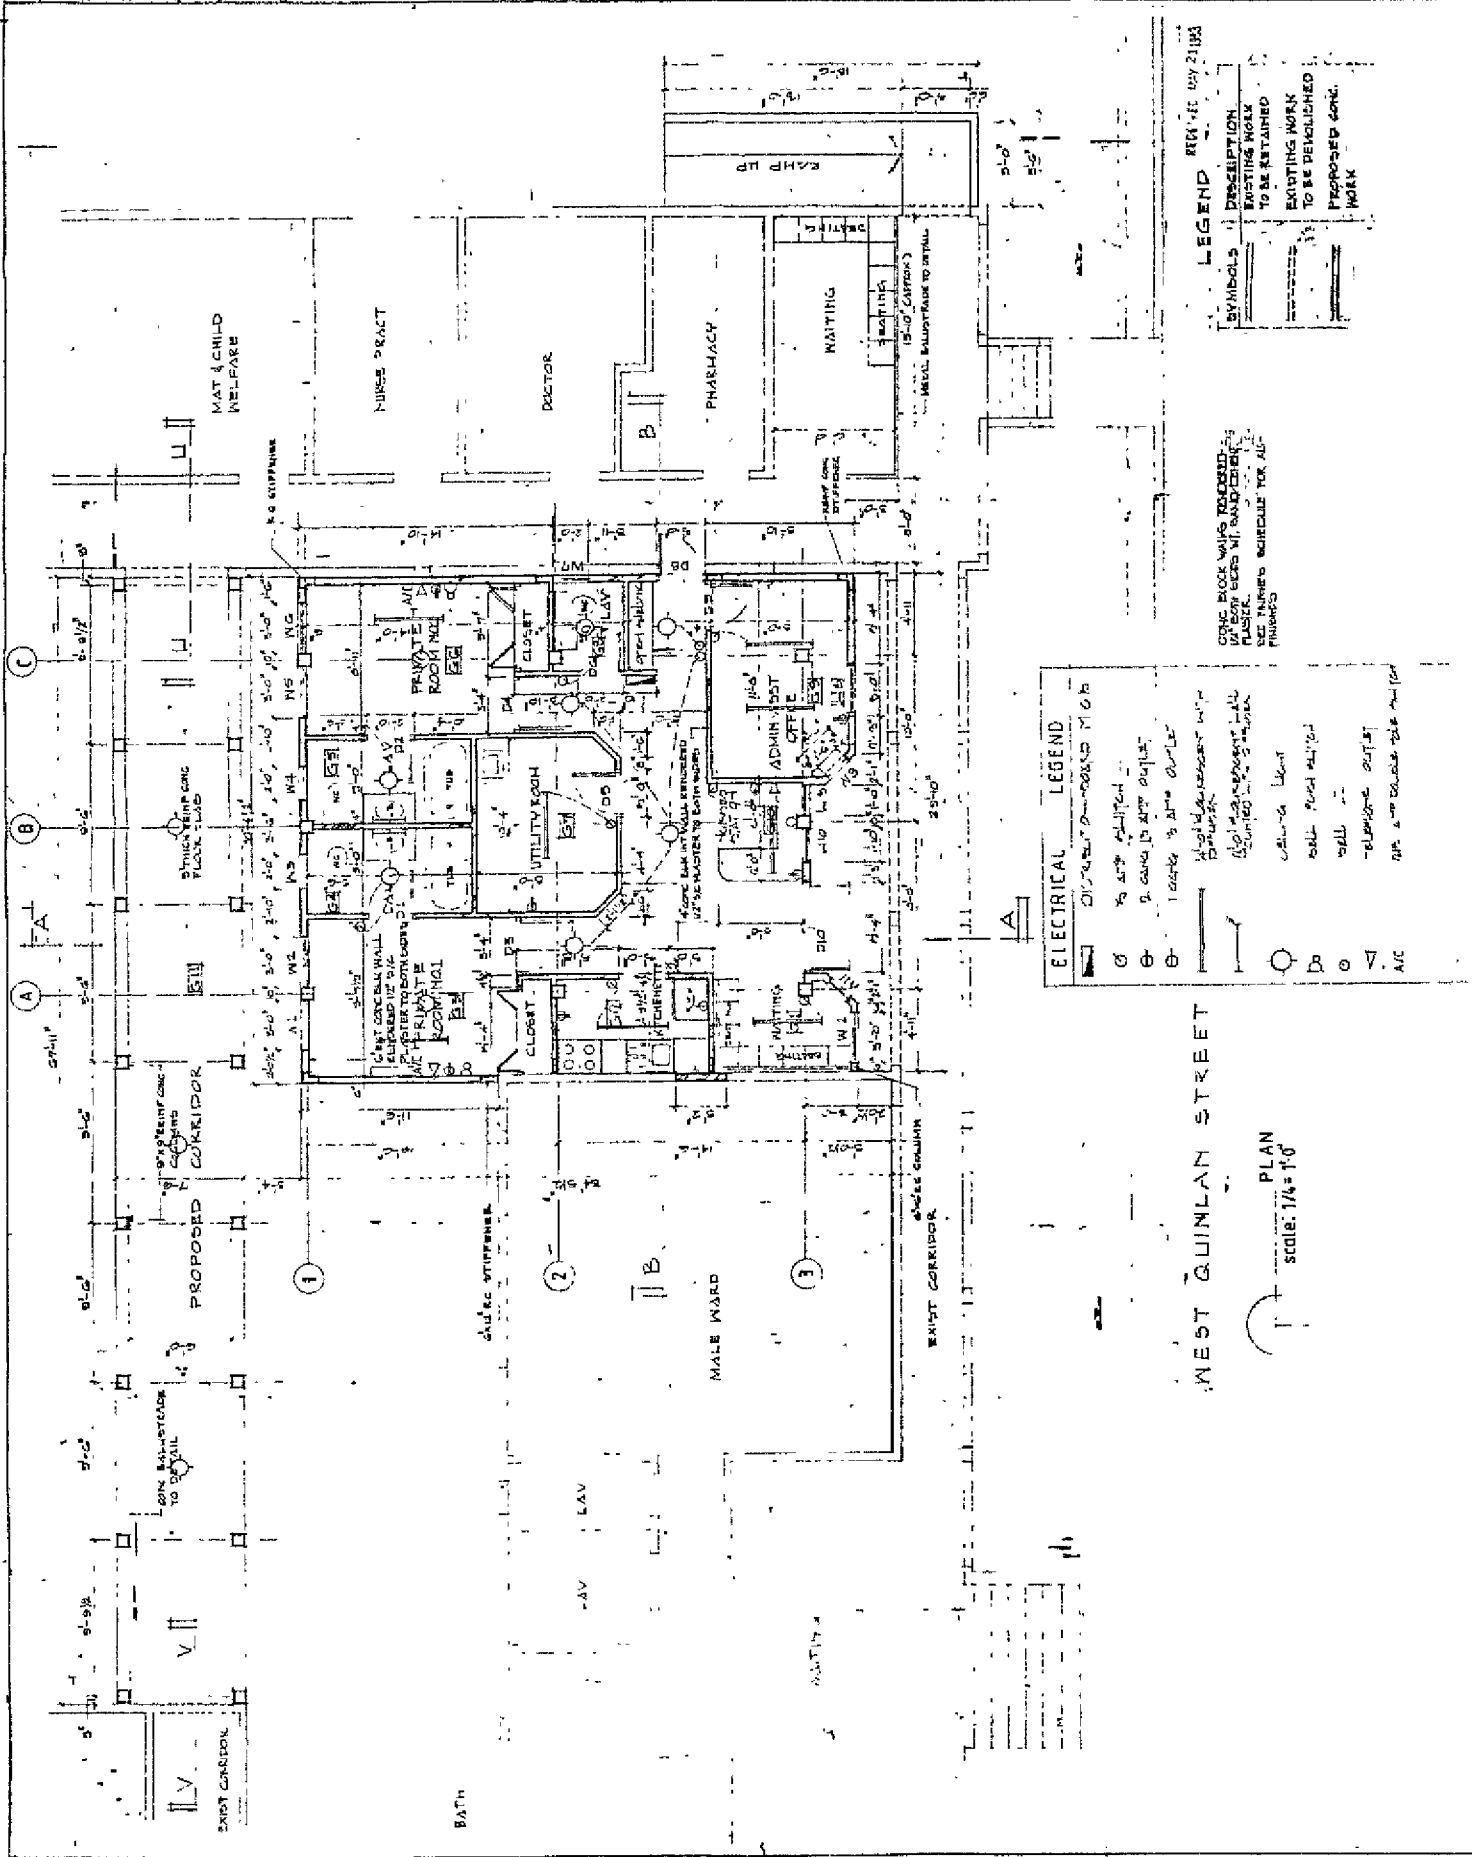

NOTES AND REVISIONS

1 DO NOT SCALE

2 CONTRACTOR TO VERIFY ALL DIMENSIONS AND LOCATIONS OF EXISTING STRUCTURE AND UTILITIES

3 ALL REVISIONS AND CORRECTIONS ARE TO BE REPORTED TO THE ARCHITECT

4 FOR ALL DETAILS OF FOUNDATION, STRUCTURE, ROOFING, MECHANICAL, ELECTRICAL, PLUMBING, AND SPECIAL ENGINEERING, THE ARCHITECT'S DETAILS OR SPECIFICATION AND DETAILS OF THE ARCHITECT SHALL BE USED

5 FOR ALL DETAILS OF MECHANICAL, ELECTRICAL, PLUMBING, AND SPECIAL ENGINEERING, THE ARCHITECT'S DETAILS OR SPECIFICATION AND DETAILS OF THE ARCHITECT SHALL BE USED

6 FOR ALL DETAILS OF MECHANICAL, ELECTRICAL, PLUMBING, AND SPECIAL ENGINEERING, THE ARCHITECT'S DETAILS OR SPECIFICATION AND DETAILS OF THE ARCHITECT SHALL BE USED

DETAIL NO. 1
SEE ARCH. PLAN


REVISION	DATE	INITIALS	REVISION DETAILS

JOB TITLE
SOUFRIERE HOSPITAL
EXTENSION

DRAWING TITLE
FLOOR PLAN

ARCHITECTURAL SECTION
CENTRAL PLANNING UNIT
POST OFFICE BOX 709
CASTRIES, SAINT LUCIA

SHEET NO.	AS SHOWN	DATE	DEC 97
AS SHOWN	AS SHOWN	DATE	DEC 97
AS SHOWN	AS SHOWN	DATE	DEC 97

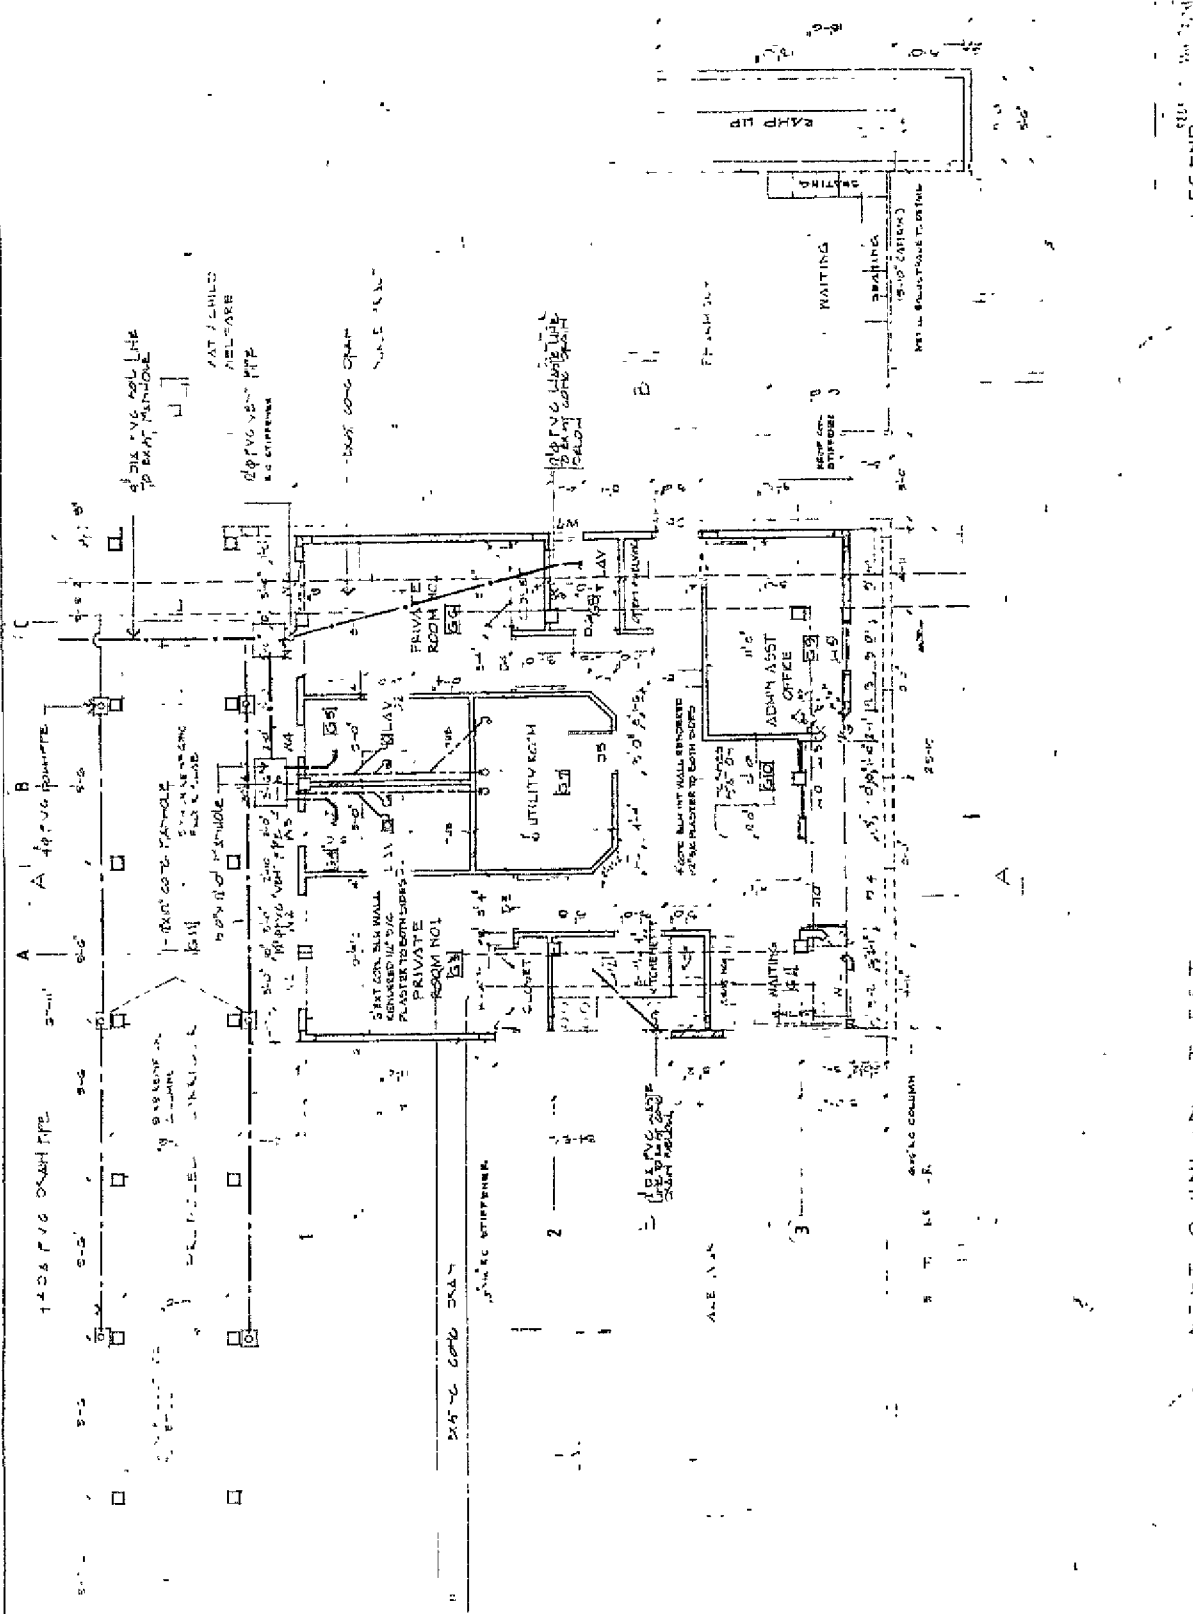

LEGEND

SYMBOLS	DESCRIPTION
=====	EXISTING WORK TO BE RETAINED
-----	EXISTING WORK TO BE DEMOLISHED
=====	PROPOSED WORK

CONC. BLOCK WALLS INDICATED IN PLAN WITH DOTTED LINE

SEE FINISH SCHEDULE FOR ALL FINISHES

SYMBOL	DESCRIPTION
=====	2' DIA. PVC DRAIN PIPE
-----	12" DIA. PVC DRAIN PIPE
=====	12" DIA. PVC DRAIN PIPE
-----	12" DIA. PVC DRAIN PIPE
=====	12" DIA. PVC DRAIN PIPE
-----	12" DIA. PVC DRAIN PIPE

PLAN
scale 1/4" = 1'0"

NORTH

DATE	JUN 1983	CHECKED	APPROVED
CRIMIN VALL			
AS STATED		REVISIONS	
SCALE			
4	01 OF 04	DRAWING NO. S 79 101	
SHEET NO.		DRAWING NO.	

NOTES AND REVISIONS

- 1 THIS DRAWING IS TO BE USED IN CONSTRUCTION
- 2 ALL DIMENSIONS ARE IN FEET AND INCHES
- 3 ALL DIMENSIONS ARE TO FACE UNLESS NOTED OTHERWISE
- 4 ALL DIMENSIONS ARE TO FACE UNLESS NOTED OTHERWISE
- 5 FOUNDATION WALLS ARE TO BE CONCRETE
- 6 FOUNDATION WALLS ARE TO BE CONCRETE
- 7 ALL STRUCTURAL CONCRETE TO BE OF 3150 PSI
- 8 IT IS THE RESPONSIBILITY OF THE CONTRACTOR TO MAINTAIN THE REINFORCEMENT IN PLACE UNTIL THE CONCRETE IS PLACED AND CURED
- 9 THIS DRAWING IS NOT TO BE USED FOR ANY OTHER PURPOSE
- 10 ALL DIMENSIONS AND LOCATIONS TO BE SHOWN ON THIS DRAWING
- 11 KEY TO CROSS REFERENCE

DETAIL NO.
REFERENCE
SHEET NO.







REVISION DATE REVISIONS

JOB TITLE
SOUTHERN HOSPITAL
PRIVATE WARD

DRAWING TITLE
FLOOR SLAB & BEAM
DETAILS

ARCHITECTURAL SECTION
CENTRAL PLANNING UNIT
POST OFFICE BOX 709
CASTRIES, SAINT LUCIA

SCALE 1/4" = 1'-0"
DATE 11/1/83
DRAWN BY
CHECKED BY
APPROVED BY

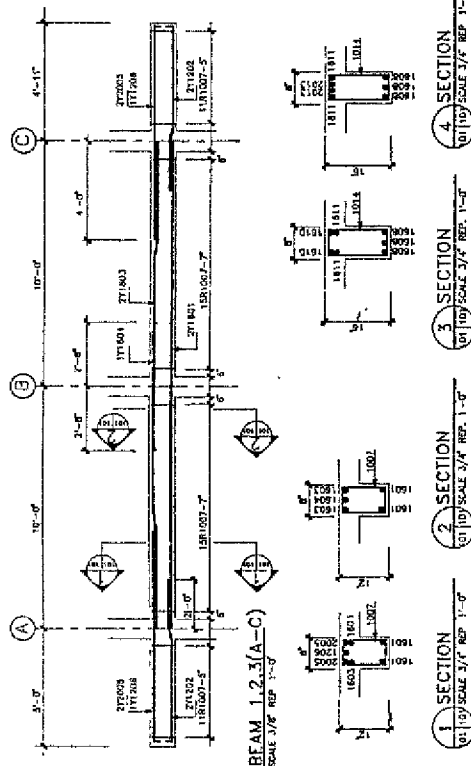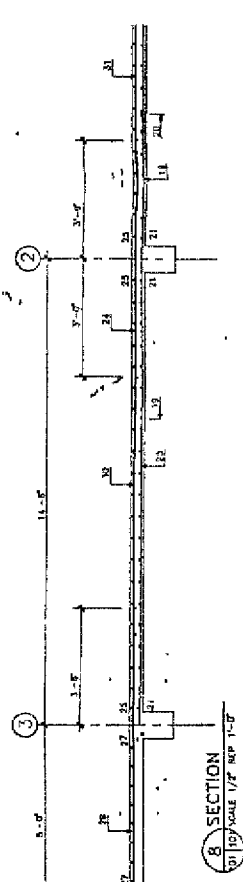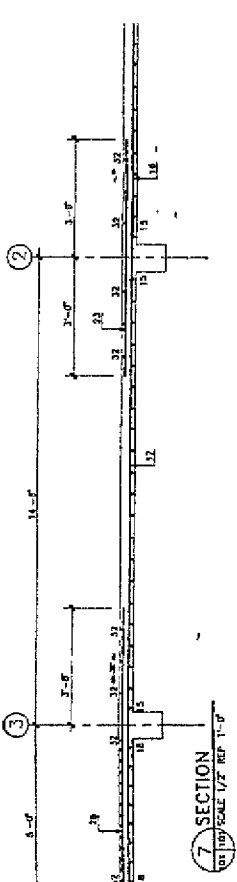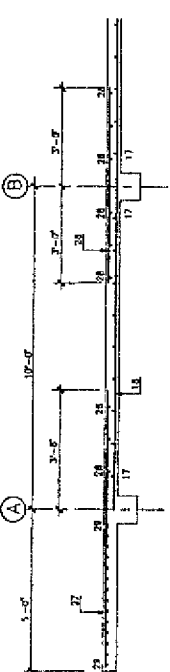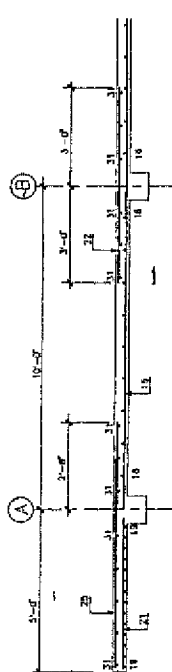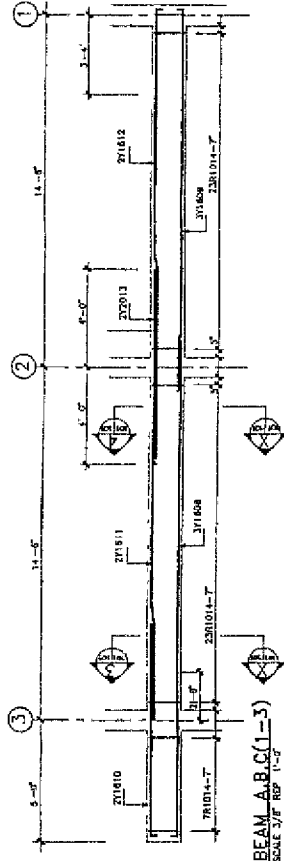

NOTES AND REVISIONS

1. THIS DRAWING IS TO BE USED IN CONJUNCTION WITH THE OTHER DRAWINGS OF THIS PROJECT.
2. ALL DIMENSIONS ARE IN FEET AND INCHES.
3. ALL DIMENSIONS ARE TO FACE UNLESS OTHERWISE NOTED.
4. ALL DIMENSIONS ARE TO FACE UNLESS OTHERWISE NOTED.
5. ALL DIMENSIONS ARE TO FACE UNLESS OTHERWISE NOTED.
6. ALL DIMENSIONS ARE TO FACE UNLESS OTHERWISE NOTED.
7. ALL DIMENSIONS ARE TO FACE UNLESS OTHERWISE NOTED.
8. ALL DIMENSIONS ARE TO FACE UNLESS OTHERWISE NOTED.
9. ALL DIMENSIONS ARE TO FACE UNLESS OTHERWISE NOTED.
10. ALL DIMENSIONS ARE TO FACE UNLESS OTHERWISE NOTED.
11. ALL DIMENSIONS ARE TO FACE UNLESS OTHERWISE NOTED.




REVISION	DATE	REVISION	DETAIL NO.

SOUFFRIERE HOSPITAL
PRIVATE WARD


DRAIN AND RING BEAM
DETAILS TO WARD

ARCHITECTURAL SECTION
CENTRAL PLANNING UNIT
POST OFFICE BOX 709
CASTRIES, SAINT LUCIA


SHEET NO.	OF NO.	DATE	BY	CHECKED	DATE

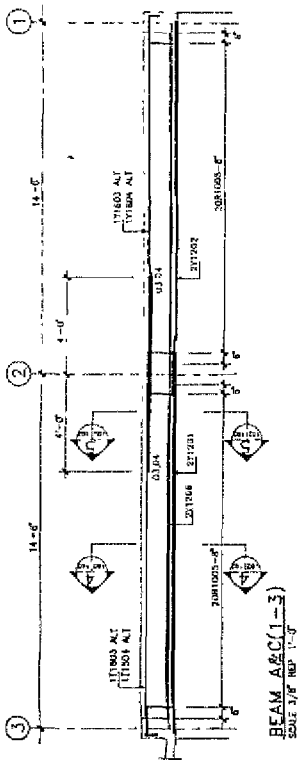

BEAM A/C(1-3)
SCALE 3/8" = 1'-0"

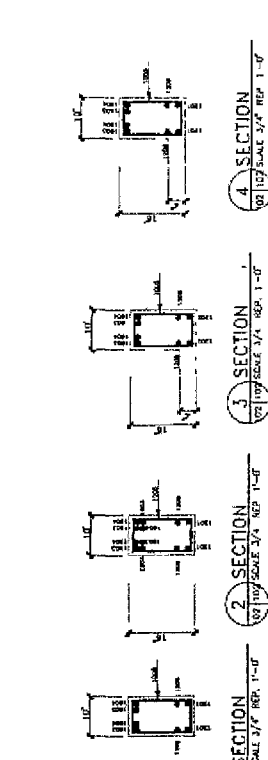

BEAM 1(A-C)
SCALE 3/8" = 1'-0"

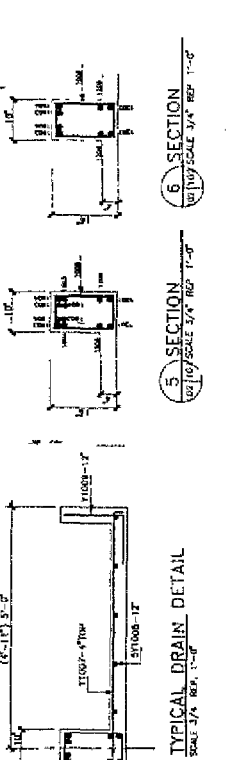


BEAM 3(A-C)
SCALE 3/8" = 1'-0"




TYPICAL DRAIN DETAIL
SCALE 3/8" = 1'-0"



SECTION 1
SCALE 3/8" = 1'-0"

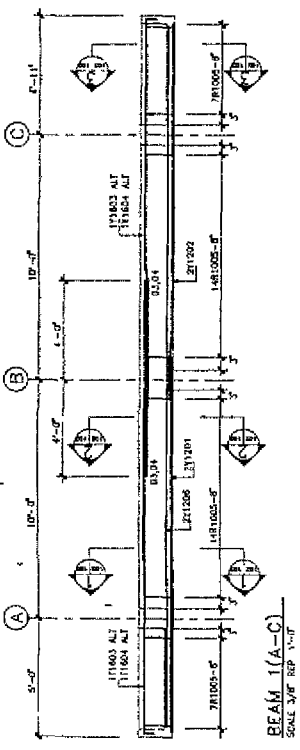

SECTION 2
SCALE 3/8" = 1'-0"

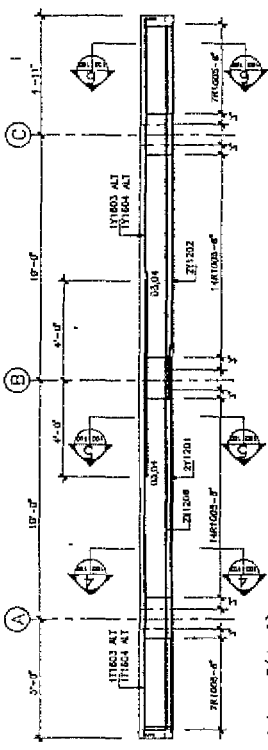


SECTION 3
SCALE 3/8" = 1'-0"



SECTION 4
SCALE 3/8" = 1'-0"



SECTION 5
SCALE 3/8" = 1'-0"

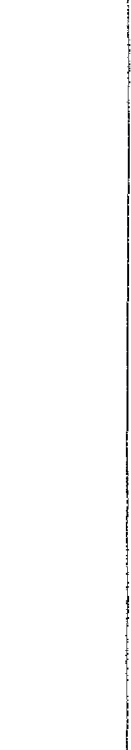

SECTION 6
SCALE 3/8" = 1'-0"

